


NOTE:
• ALL HOLES TO BE Ø22.

							DRAWN	DEEPAK	18.05.17
							CHECKED	Rajiv	31/05/17
							CHIEF DRAUGHTSMAN	DEEPAK	31.05.17
							TEAM LEADER	Rifesh-K	31.05.17
0	ORIGINAL ISSUE	31.05.17	DDC				ENGINEER	Lenoa	31/05/17
No.	REVISION	DATE	BY	CHK	PSD	APP	HEAD OF DEPARTMENT		


FIJI ELECTRICITY AUTHORITY

STANDARD HOLE DETAILS FOR FEA
17m, 15.5m TUBULAR POLES

DRAWING NUMBER			
A3	01	E43	042
SCALE		NTS	

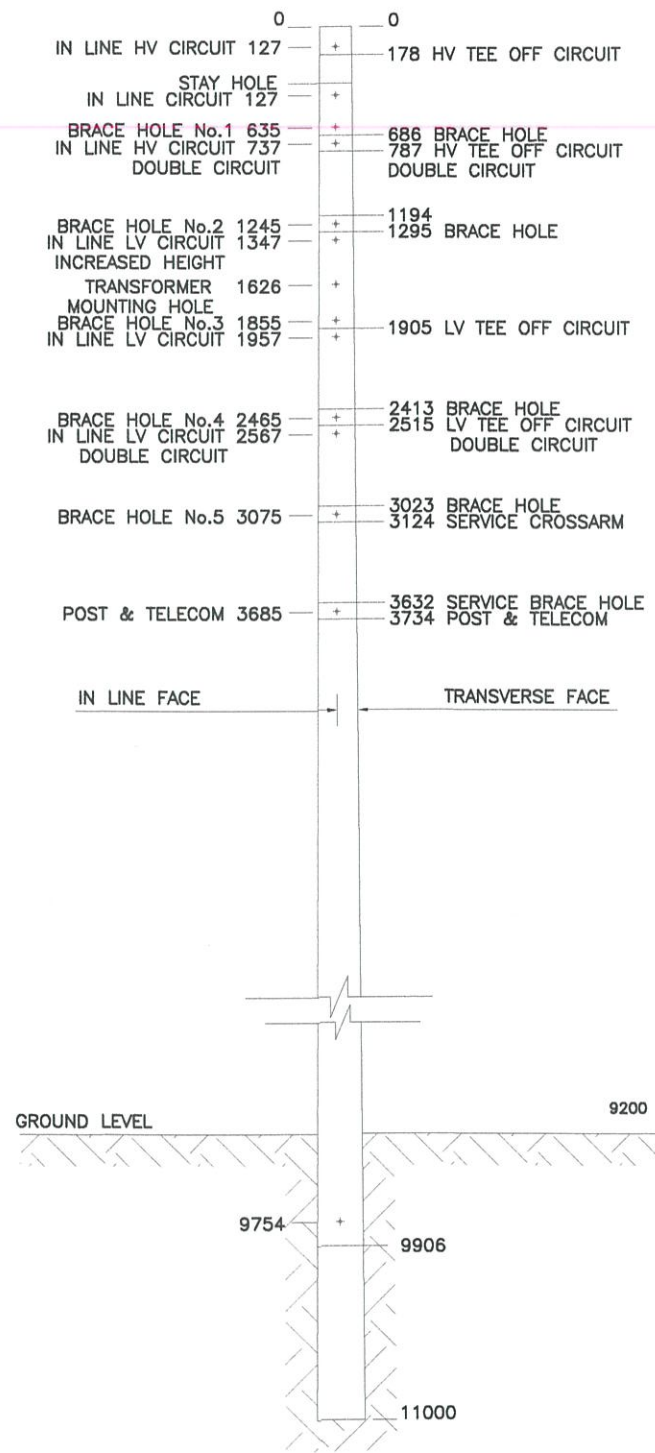

POLE TYPE 3
11m

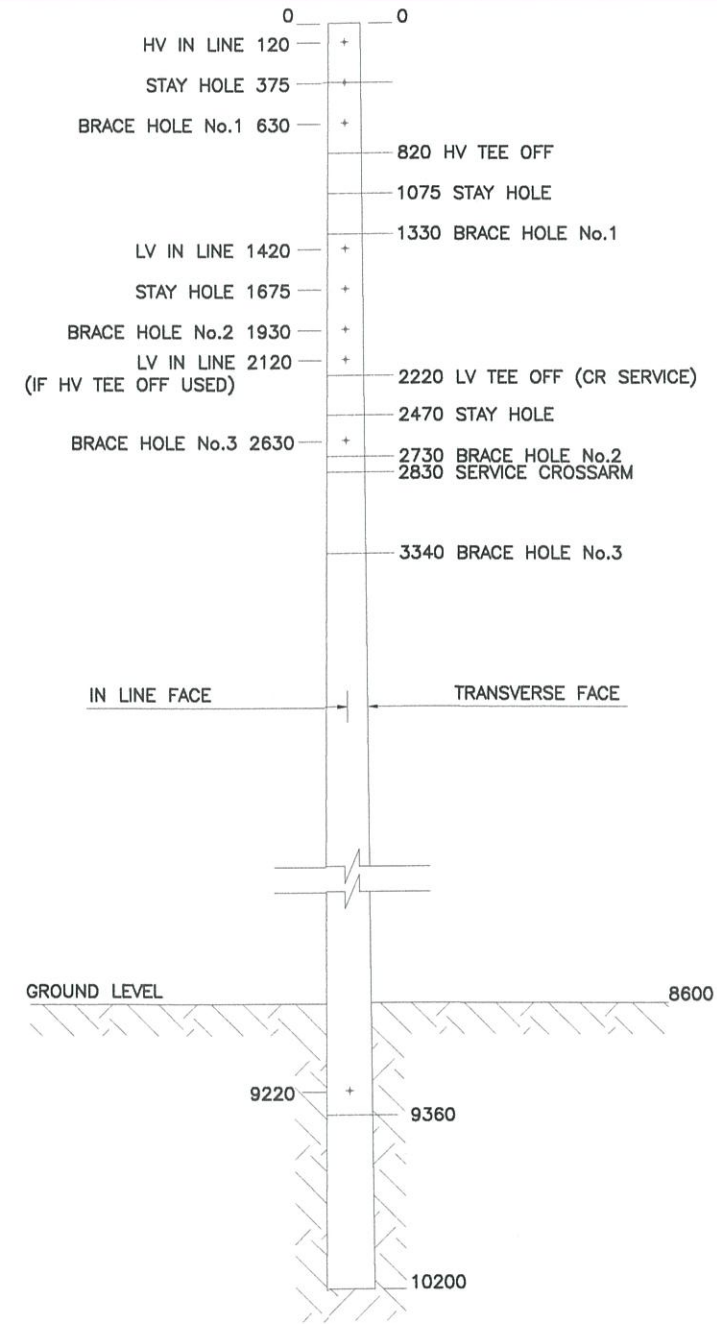

POLE TYPE 4
10.2m

NOTE:
• ALL HOLES TO BE Ø22.

							DRAWN	DEEPAK	18.05.17	FIJI ELECTRICITY AUTHORITY			
							CHECKED	Rajiv	31/05/17				
							CHIEF DRAUGHTSMAN	DEEPAK	31.05.17	STANDARD HOLE DETAILS FOR FEA 11m & 10.2m TUBULAR SPUN CONCRETE POLES			
							TEAM LEADER	Ritesh.K	31.05.17				
							ENGINEER	Lenea	31/05/17	DRAWING NUMBER			
							HEAD OF DEPARTMENT	Accountant	31/5/17	A3	01	E43	042
No.	REVISION	DATE	BY	CHK	PSD	APP					SCALE	NTS	
0	ORIGINAL ISSUE	31.05.17	DDC										