
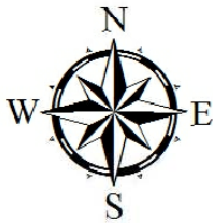


INITIAL PLAN FOR

DESIGN-BUILD WWTP & LIFT STATION UPGRADE

AMERICAN SAMOA POWER AUTHORITY

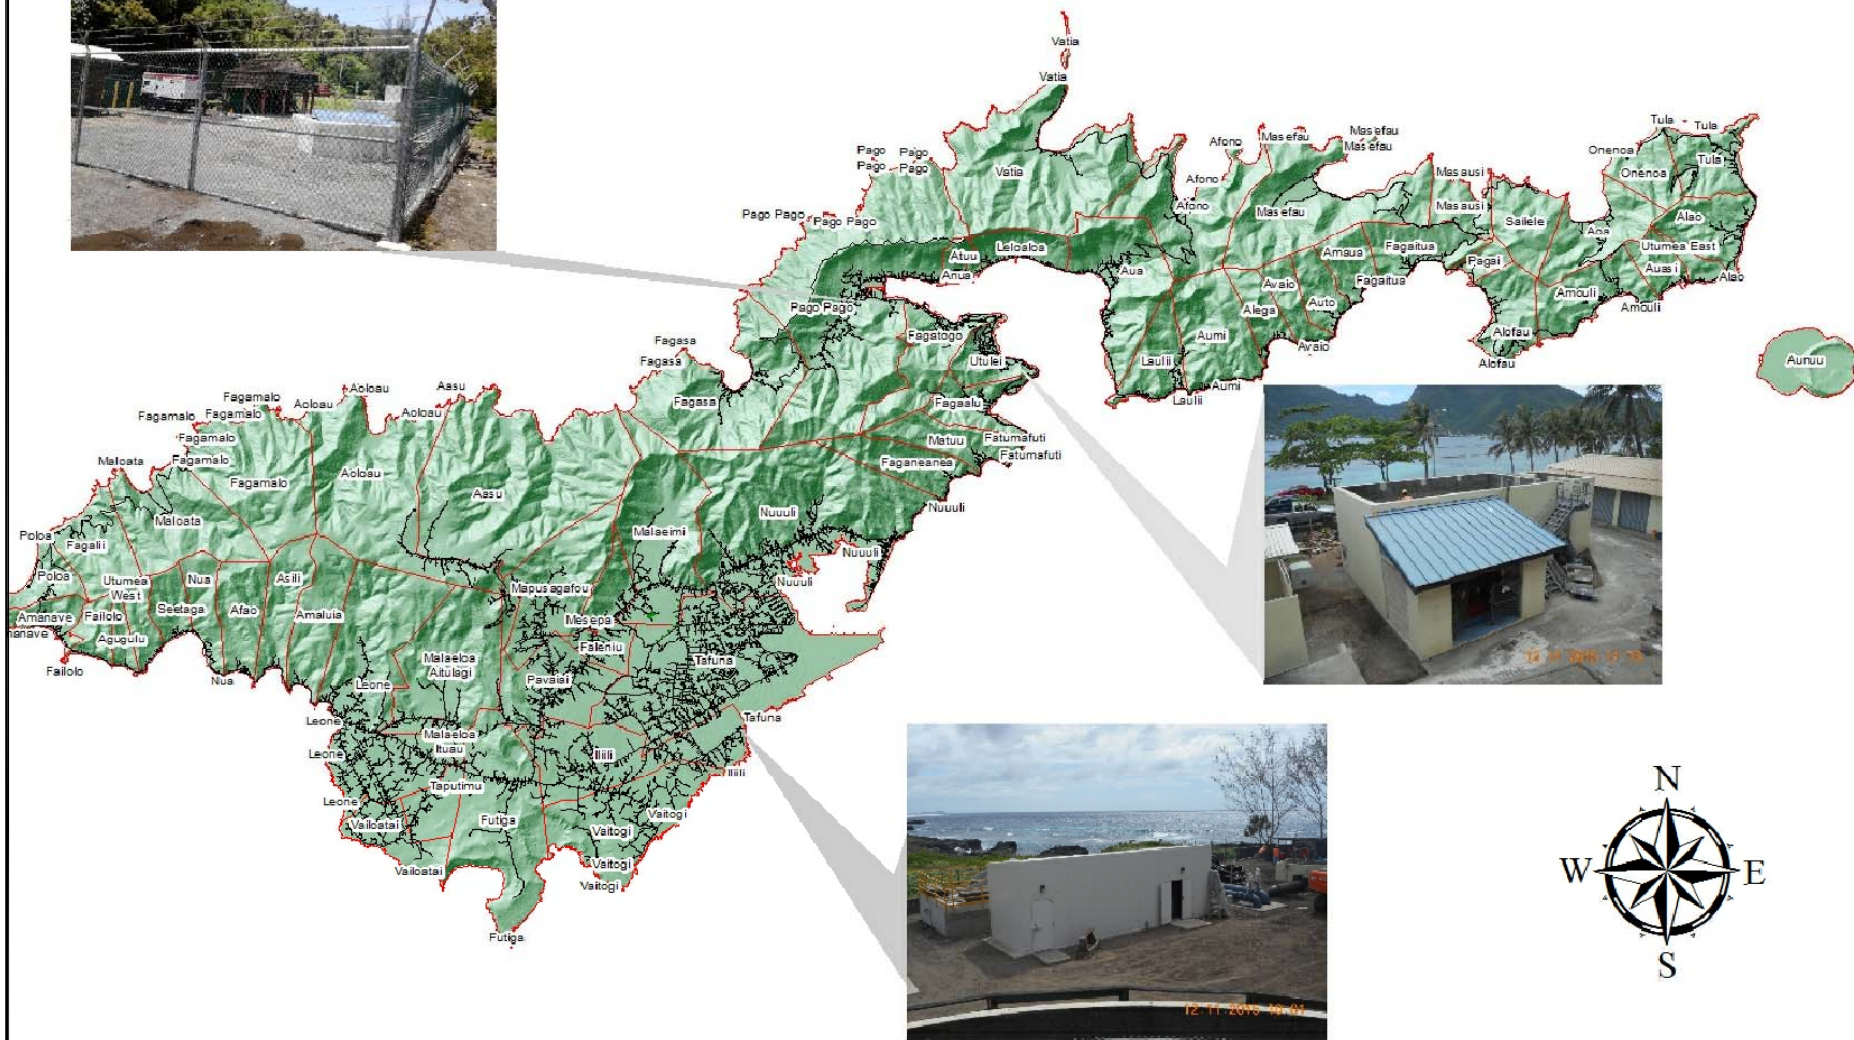

INDEX TO DRAWINGS

SHEET NO.	DESCRIPTION
1	COVER PAGE
2	MALALOA LIFT STATION SITE PLAN
3	FOGAGOGO WWTP SITE PLAN
4	UTULEI WWTP SITE PLAN
5	TELESCOPING VALVE LOCATION

PREPARED BY:
WALDIE ALLEN & EDMON

DESIGNED BY:
EDMON O. LACAULAN, CE

APPROVED BY:
JASON JASKOWIAK, PE

ISSUE FOR:
DRAFT



AMERICAN SAMOA POWER AUTHORITY

WASTE WATER ENGINEERING SERVICES DIVISION
TAFUNA, AMERICAN SAMOA
P.O.BOX PPB, PAGO PAGO AM SAMOA 96799. TEL(684) 699-7198, FAX (684) 699-9675

PROJECT NAME:
PROPOSED WWTP & LIFT STATION
UPGRADE

DRAWING TITLE:
COVER PAGE

PROJECT LOCATION:
TAFUNA AS 96799

REVISION HISTORY:

NO.	DATE	DETAILS OF REVISION	REVISED BY
1	5/21/2017 1:52 PM		EDMON

SCALE:

AS SHOWN


PROJECT #:

123456

SHEET NO.

1
OF
5

DATE PLOTTED: Monday, July 03, 2017 by: Edmon

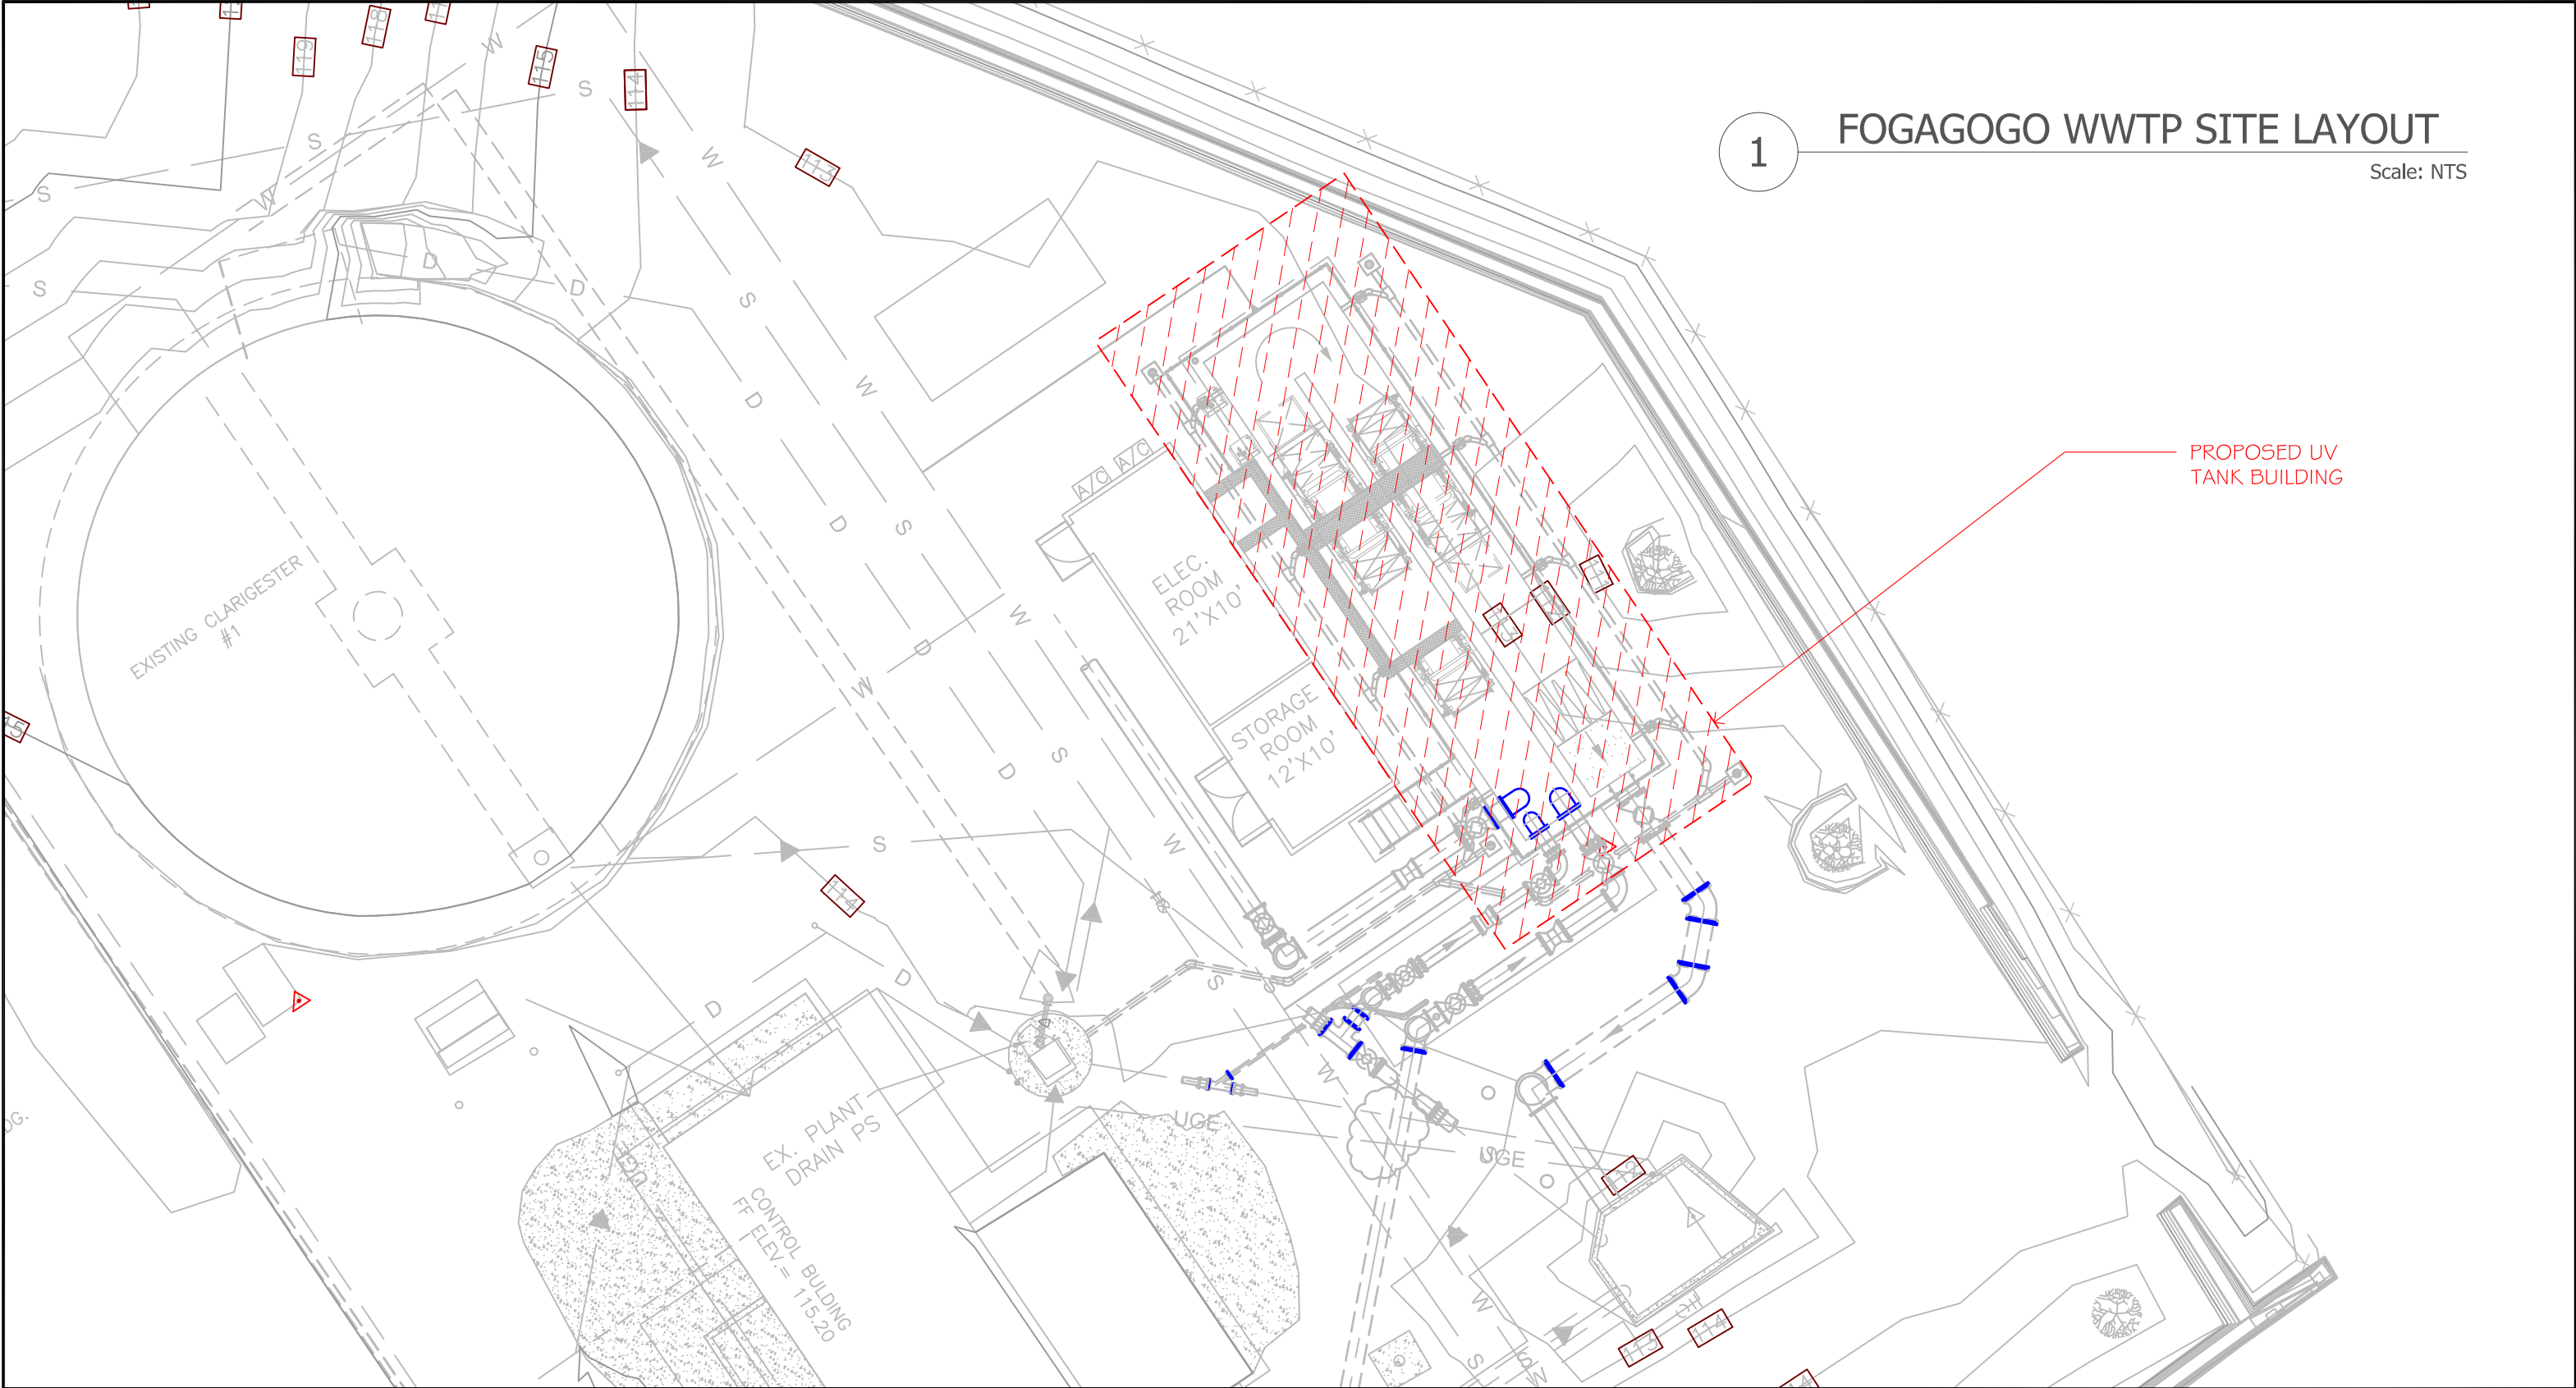

1

FOGAGOGO WWTP SITE LAYOUT

Scale: NTS

PROPOSED UV
TANK BUILDING

PREPARED BY:
EDMON O. LACAULAN, CE

DESIGNED BY:
EDMON O. LACAULAN, CE

APPROVED BY:
JASON JASKOWIAK, PE

ISSUE FOR:
DRAFT



AMERICAN SAMOA POWER AUTHORITY

WASTE WATER ENGINEERING SERVICES DIVISION
TAFUNA, AMERICAN SAMOA
P.O.BOX PPB, PAGO PAGO AM SAMOA 96799. TEL(684) 699-7198, FAX (684) 699-9675

PROJECT NAME:
PROPOSED WWTP & LIFT STATION
UPGRADE

DRAWING TITLE:
FOGAGOGO WWTP SITE PLAN

PROJECT LOCATION:
TAFUNA AS 96799

REVISION HISTORY:


NO.	DATE	DETAILS OF REVISION	REVISED BY
1	6/28/2017 12:41 PM		EDMON

SCALE:
AS SHOWN

PROJECT #:
123456

SHEET NO.
3
OF
5

DATE PLOTTED: Wednesday, June 28, 2017 by: Edmon

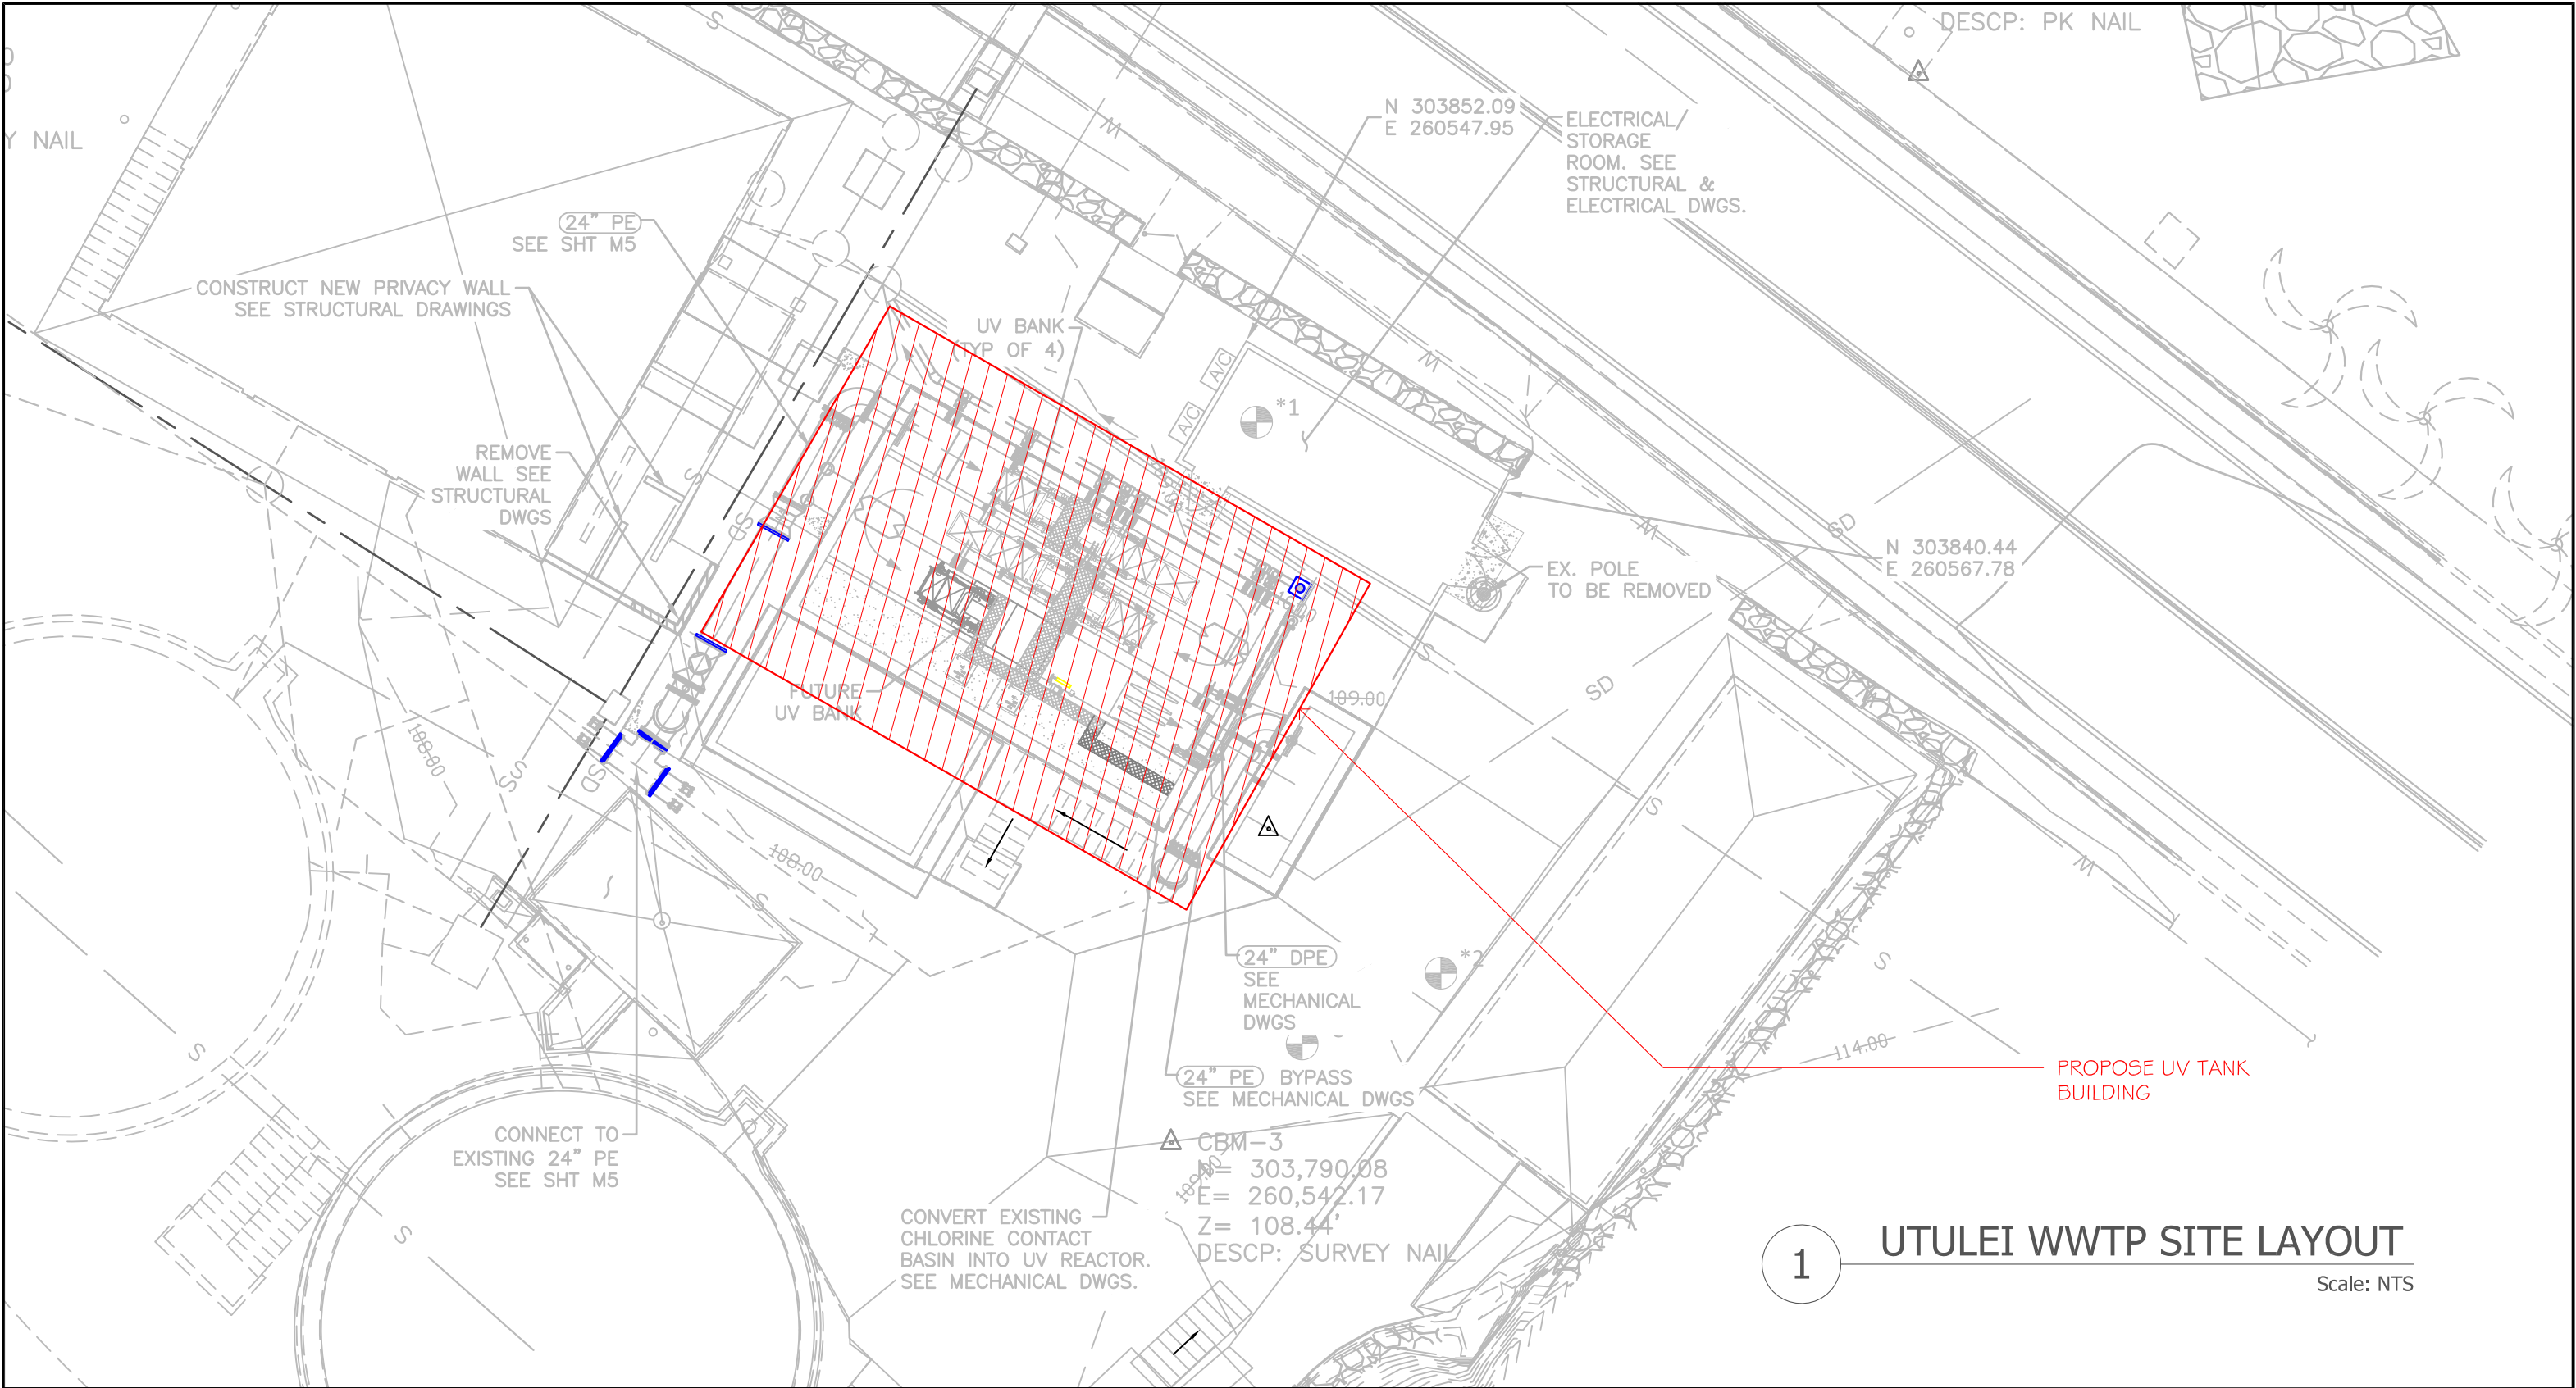

1 UTULEI WWTP SITE LAYOUT
Scale: NTS

PREPARED BY: EDMON O. LACAULAN, CE
DESIGNED BY: EDMON O. LACAULAN, CE
APPROVED BY: JASON JASKOWIAK, PE
ISSUE FOR: DRAFT




AMERICAN SAMOA POWER AUTHORITY


WASTE WATER ENGINEERING SERVICES DIVISION
TAFUNA, AMERICAN SAMOA
P.O.BOX PPB, PAGO PAGO AM SAMOA 96799. TEL(684) 699-7198, FAX (684) 699-9675

PROJECT NAME: PROPOSED WWTP & LIFT STATION UPGRADE
DRAWING TITLE: UTULEI WWTP SITE LAYOUT
PROJECT LOCATION: TAFUNA AS 96799

REVISION HISTORY:				SCALE:
NO.	DATE	DETAILS OF REVISION	REVISED BY	AS SHOWN
1	6/21/2017 10:52 AM		EDMON	PROJECT #: 123456
				SHEET NO.
				4 OF 5

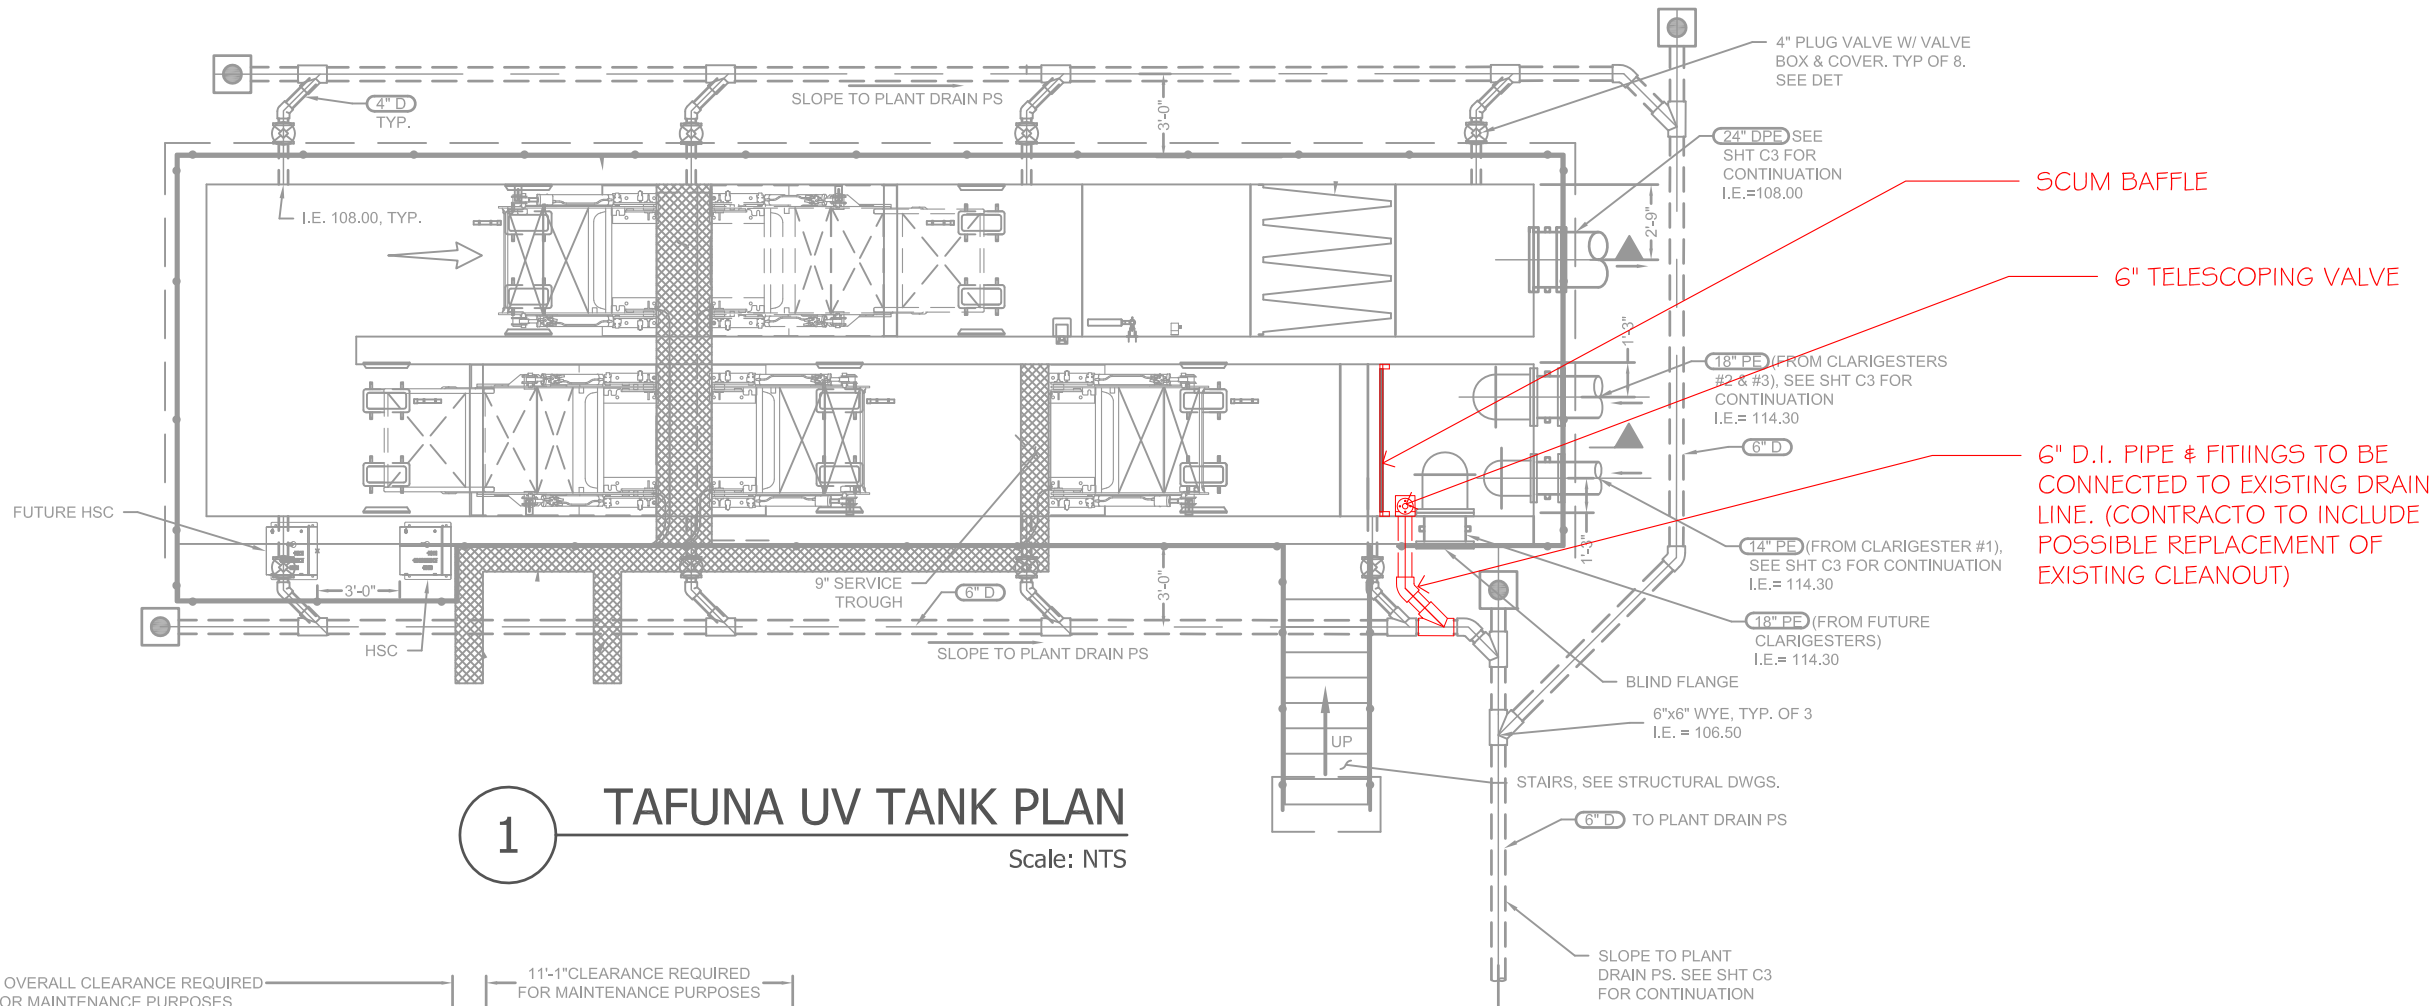

1 TAFUNA UV TANK PLAN
Scale: NTS

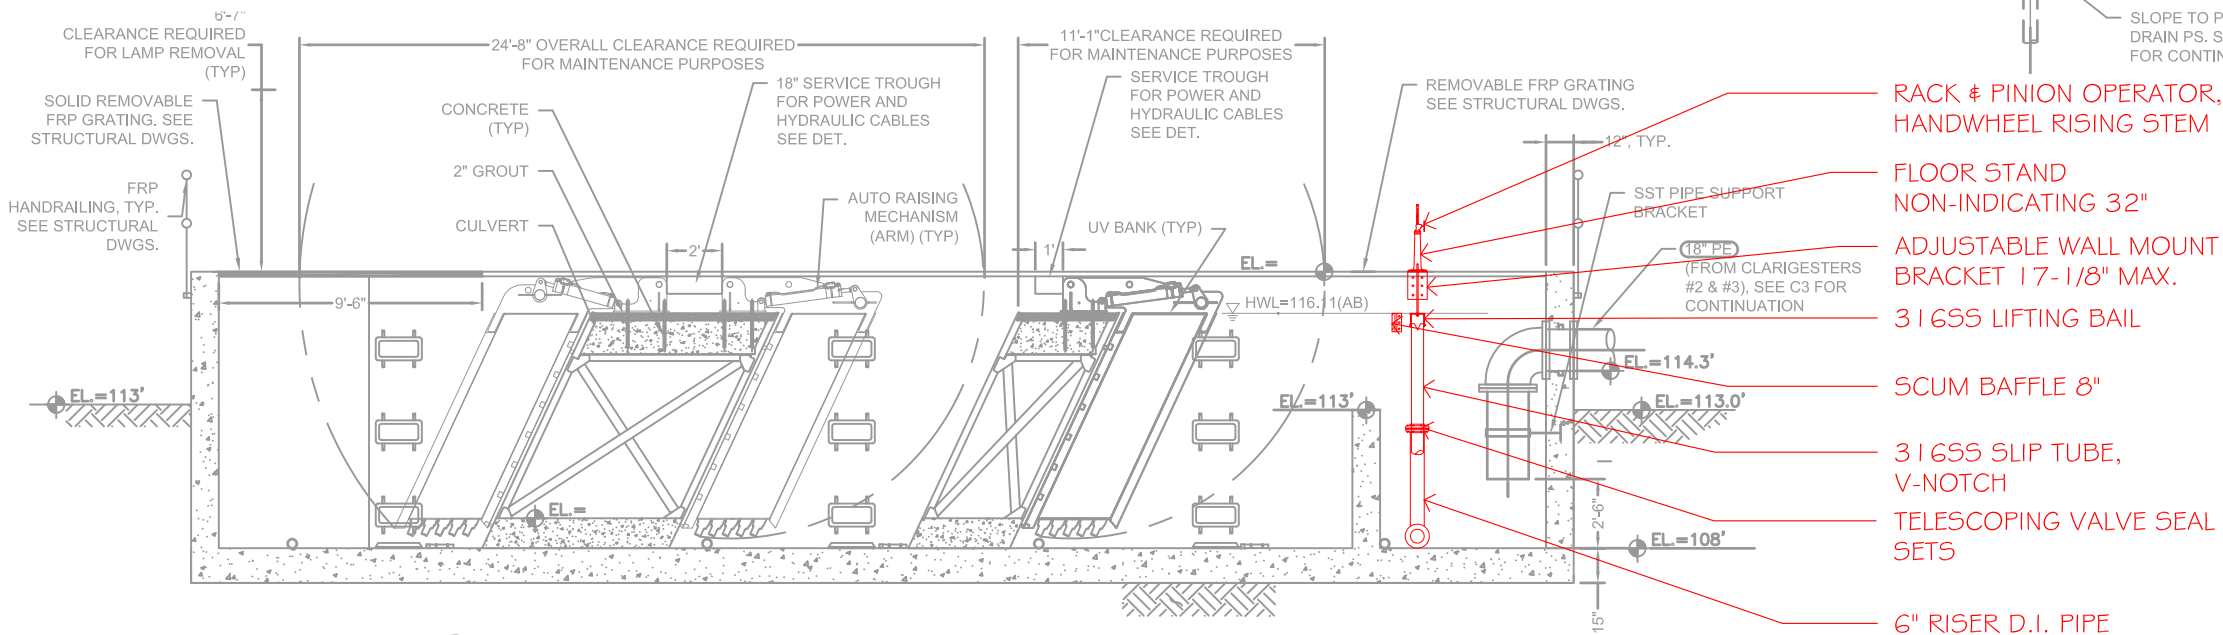

2 TAFUNA UV TANK LONG. SECTION
Scale: NTS

PREPARED BY: EDMON O. LACAULAN, CE
DESIGNED BY: EDMON O. LACAULAN, CE
APPROVED BY: JASON JASKOWIAK, PE
ISSUE FOR: DRAFT



AMERICAN SAMOA POWER AUTHORITY

WASTE WATER ENGINEERING SERVICES DIVISION
TAFUNA, AMERICAN SAMOA
P.O.BOX PPB, PAGO PAGO AM SAMOA 96799. TEL(684) 699-7198, FAX (684) 699-9675

PROJECT NAME: PROPOSED WWTP & LIFT STATION UPGRADE
DRAWING TITLE: TELESCOPING VALVE PROPOSED LOCATION
PROJECT LOCATION: TAFUNA AS 96799

REVISION HISTORY:			
NO.	DATE	DETAILS OF REVISION	REVISED BY
1	6/28/2017 12:28 PM		EDMON

SCALE: AS SHOWN
PROJECT #: 123456
SHEET NO. 5 OF 5